
 


APPENDIX A

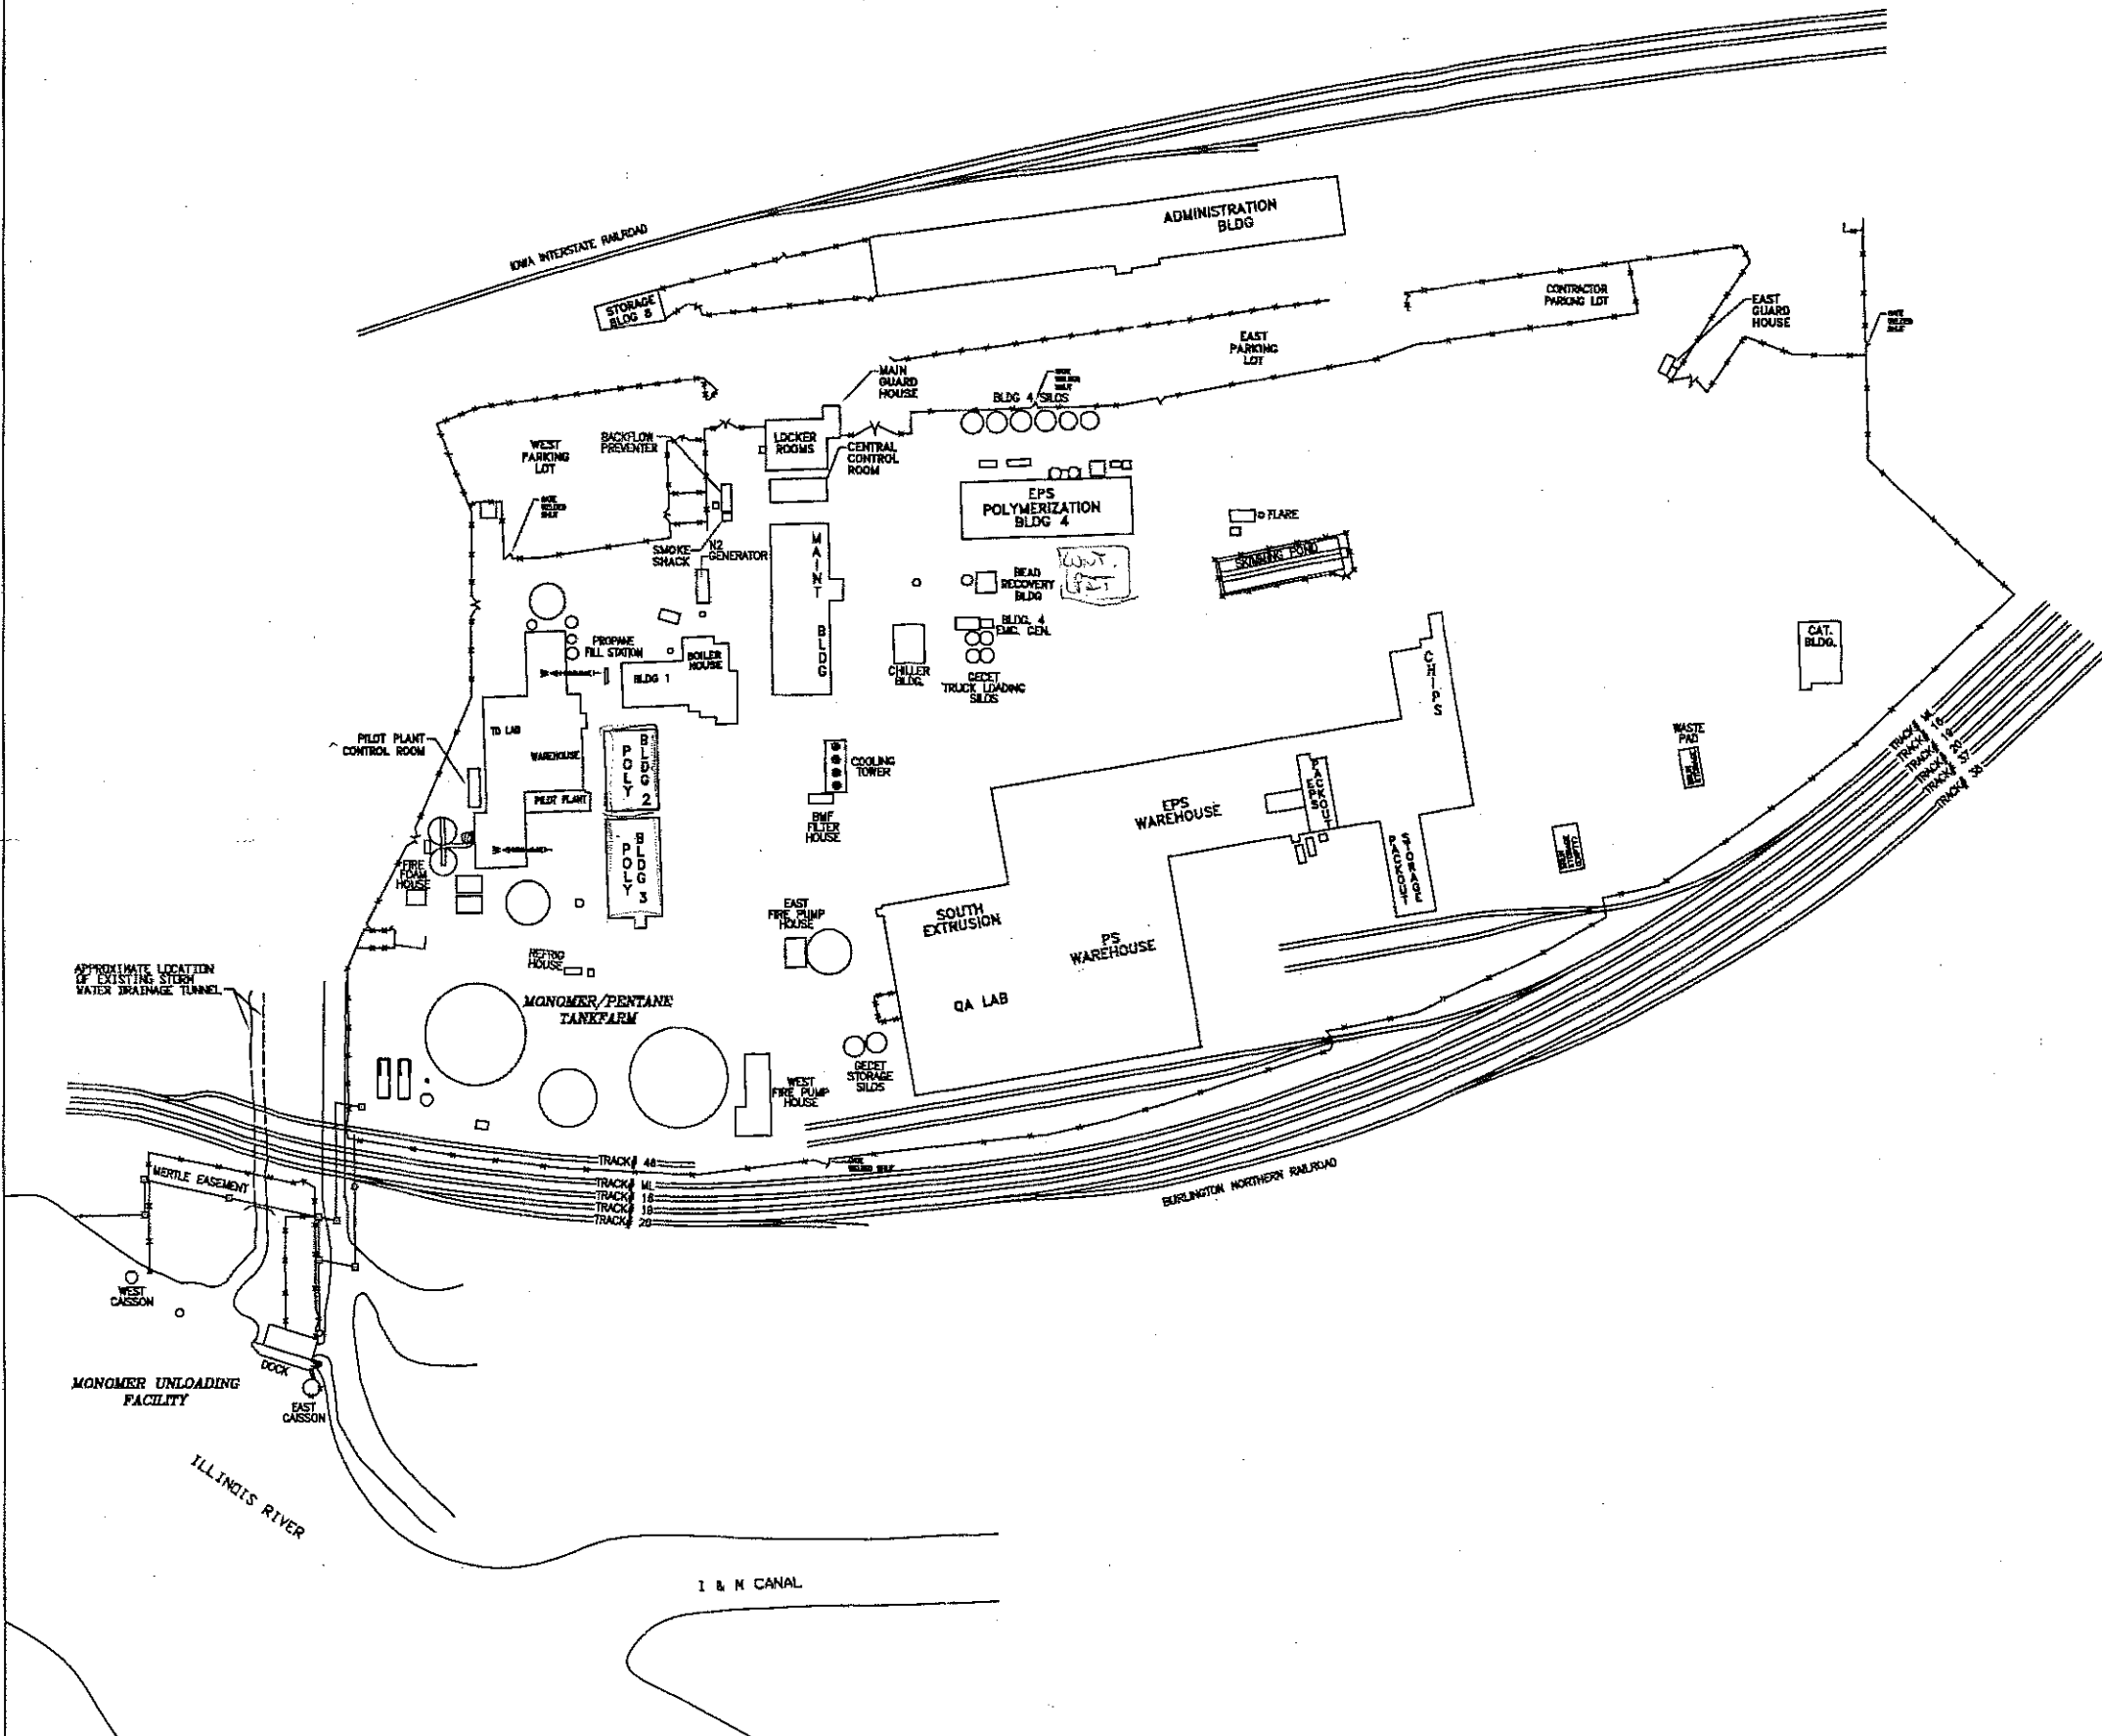

LAYER CHART	
LAYER	ON
0	✓
ASBESTOS ROOFING MATL	
ASBESTOS SAMPLE POINTS	
ASBESTOS LOCATION TYPES	
BUILDING	✓
CO JURISDICTION BOUNDARY	
CONCRETE	
CONTOUR	
DIKE	
DIMENSION	
DOCK	✓
ELECTRICAL AREA CLASS	
ELECTRICAL	
ELEVATIONS	
EMERGENCY ASSY AREAS	
EMISSION STACKS	
EQUIPMENT	
EVACUATION AREAS	
EVACUATION ROUTES	
FACILITY FUEL OIL SPOC	
FENCE	✓
FIBER OPTICS	
FIBER OPTIC WIRES	
FIRE ALARM	
FIRE ALARM RISER	
FIRE ALARM COMM (1)	
FIRE ALARM COMM 1 TEXT	
FIRE ALARM COMM (2)	
FIRE ALARM COMM 2 TEXT	
FIRE ALARM DEVICE ID's	
FIRE ALARM DEVICE LOCATIONS	
FIRE/SPRINKLER LOOP	
FIRE RES'D	
GRID	
HEARING PROTECTION	
LAN	
LAN AREA	
MECHANICAL INTEGRITY	
MISC-BLDG	✓
MISC-UNDERGROUND	
NOISE TEST LOCATIONS	
PIPERACK	
PIPERACK TEXT	
PLANT PAGING SYS	
POST	
PRE-PLAN	
RAILROAD	✓
REV	✓
ROAD	
SANITARY SEWER	
SECURE RESTRICTED AREA	
SECURITY CAMERA (I/C)	
SPOT	
SPLIT	
SPUR	✓
STORM SEWER	
STORM WATER DRAINAGE	
TANK	✓
TANK TEXT	
UTILITY	

- LEGEND**
- POST
 - S SIGN POST
 - MANHOLE
 - ⊗ MANHOLE (CAPPED)
 - ⊞ SHUT-OFF VALVE
 - △ FIRE HYDRANT
 - ⊙ FIRE HYDRANT MANIFOLD
 - ⊙ FIRE HOUSE
 - ⊙ FIRE MAIN INDICATOR
 - ⊙ FIRE ALARM PULL STATION (NON EXP)
 - ⊙ LIGHT POLE
 - ⊙ POWER POLE
 - ⊙ JUNCTION BOX
 - ⊙ STOP GATE
 - ⊙ CATCH BASIN
 - ⊙ TRANSFORMER
 - FENCE LINE
 - ELECTRIC
 - UNDERGROUND ELECTRIC
 - UNDERGROUND GAS
 - UNDERGROUND TELEPHONE
 - UNDERGROUND WATER
 - SANITARY SEWER
 - STORM SEWER
 - COAST GUARD JURISDICTIONAL BOUNDARY



Flint Hills Resources
PERU, ILLINOIS PLANT

X 2/16/PER DCR 2016-001 W 12/15/PER MOC 156129 V 2/19/PER DCR 2015-001 U 11/11/PER MOC 166499 T 10/11/PER MOC 156919	NAME: SITE PLOTPLAN FLINT HILLS RESOURCES DRAWN BY: TJB DATE: 8/28/96 SCALE: GRID=100' PLOT SCALE: 1"=1100' VERSION: 1E SHEET: 1 REV# X
--	---

THE INFORMATION, DATA AND DESIGN SHOWN HEREIN ARE THE CONFIDENTIAL PROPERTY OF FLINT HILLS RESOURCES, LP. NO USE OR REPRODUCTION MAY BE MADE WITHOUT SPECIFIC WRITTEN APPROVAL FROM FLINT HILLS RESOURCES, LP.